



Silver Lake Reservoir Complex Modular Office Project

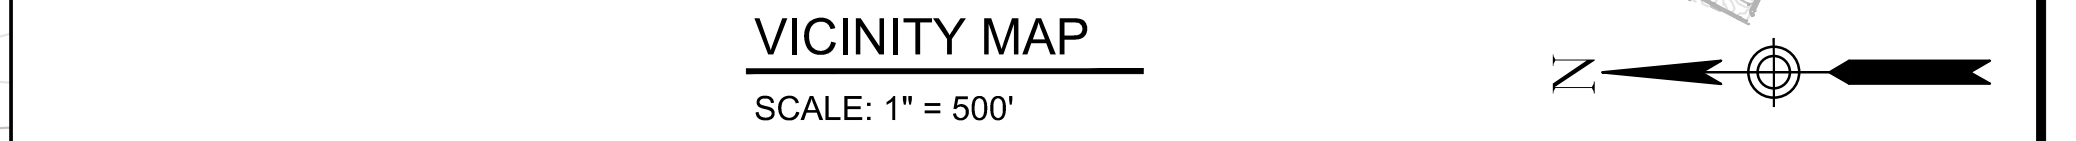

D06007-C-130

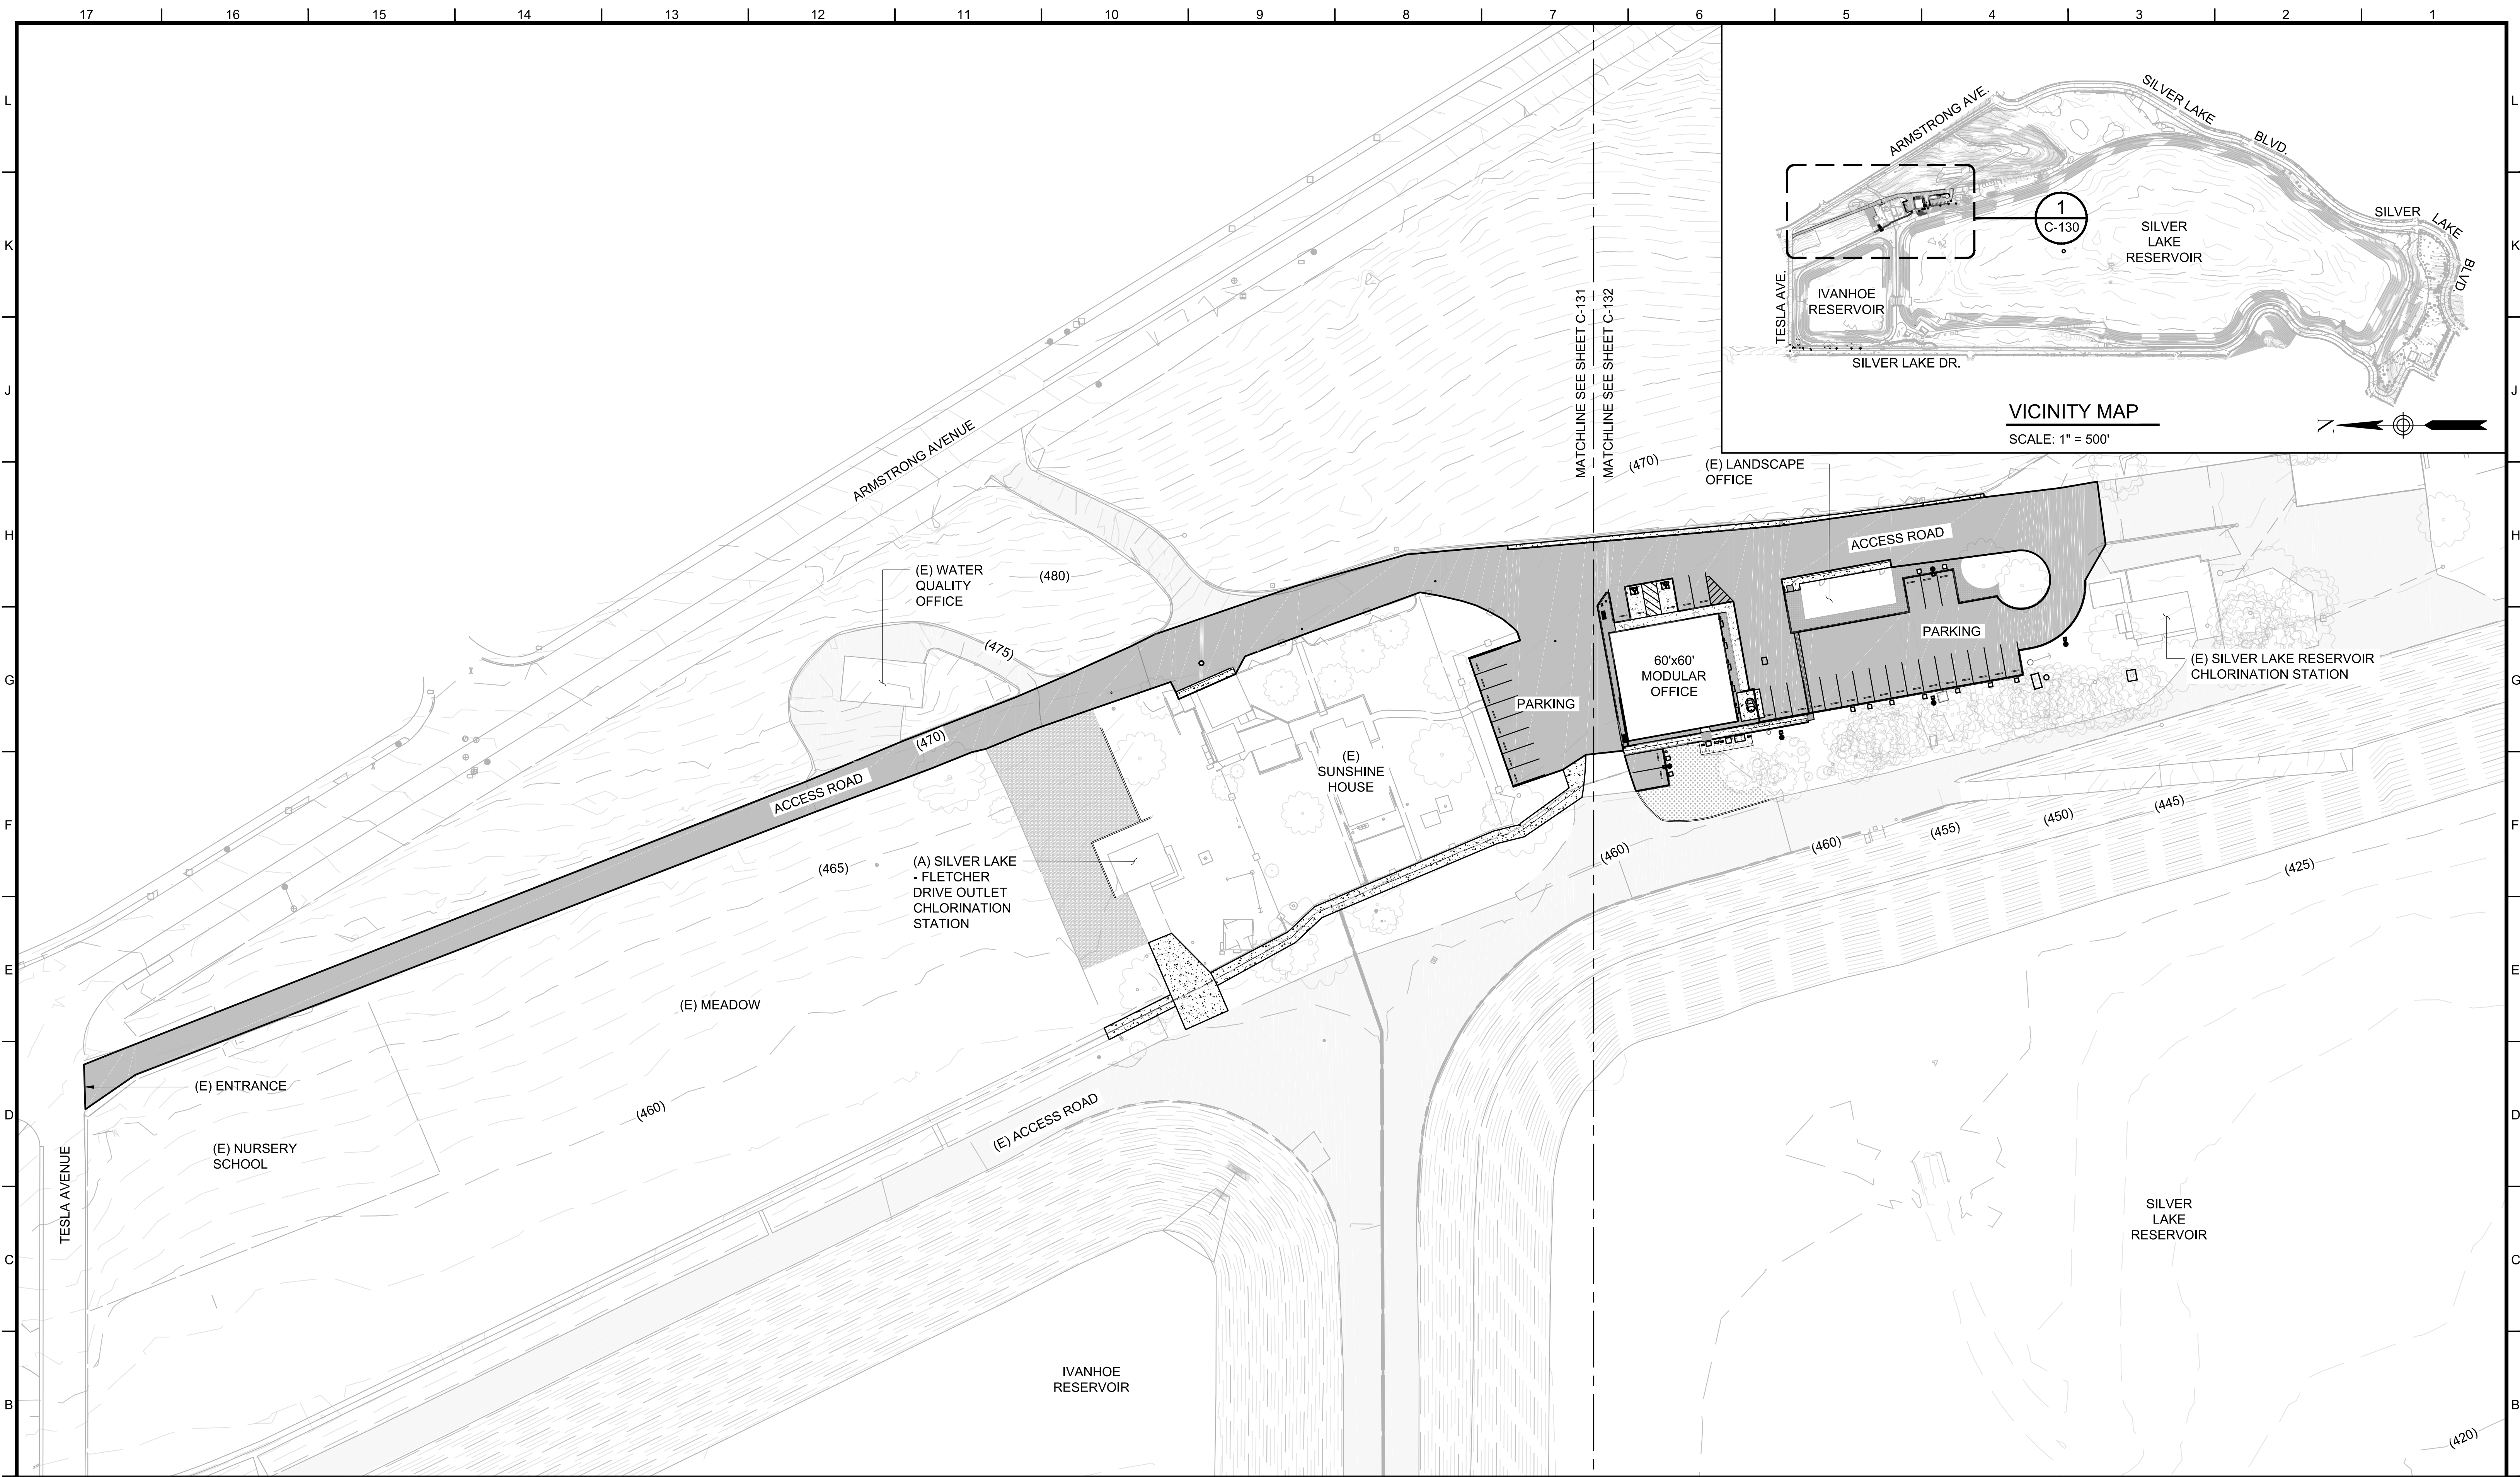

SITE PLAN
SCALE: 1" = 40'-0"

1
C-130

100% DESIGN
NOT FOR CONSTRUCTION

REVISIONS					
Number	Date	Initials	Location	Description	Approved

REFERENCES		
File Name	Scale	AS SHOWN
C-130 SITE.DWG	1" = 40'-0"	AS SHOWN


DATE	APPROVED	DATE
08/19	AS TO DESIGN	08/19
08/19	ANDREW L. LINARD	08/19
08/19	AS TO OPERATION	08/19
08/19	ANSELMO G. COLLINS	08/19
09/03/19	AS TO DISTRIBUTION	08/19
08/19	BREONIA L. LINDSEY	08/19
08/19	Senior Assistant GM of Water	08/19
08/19	RICHARD F. HARASICK	08/19

SILVER LAKE RESERVOIR MODULAR OFFICE
SITE PLAN


DEPARTMENT OF WATER AND POWER
CITY OF LOS ANGELES

DRAWING NUMBER
D06007-C-130

VERSION: 01.0

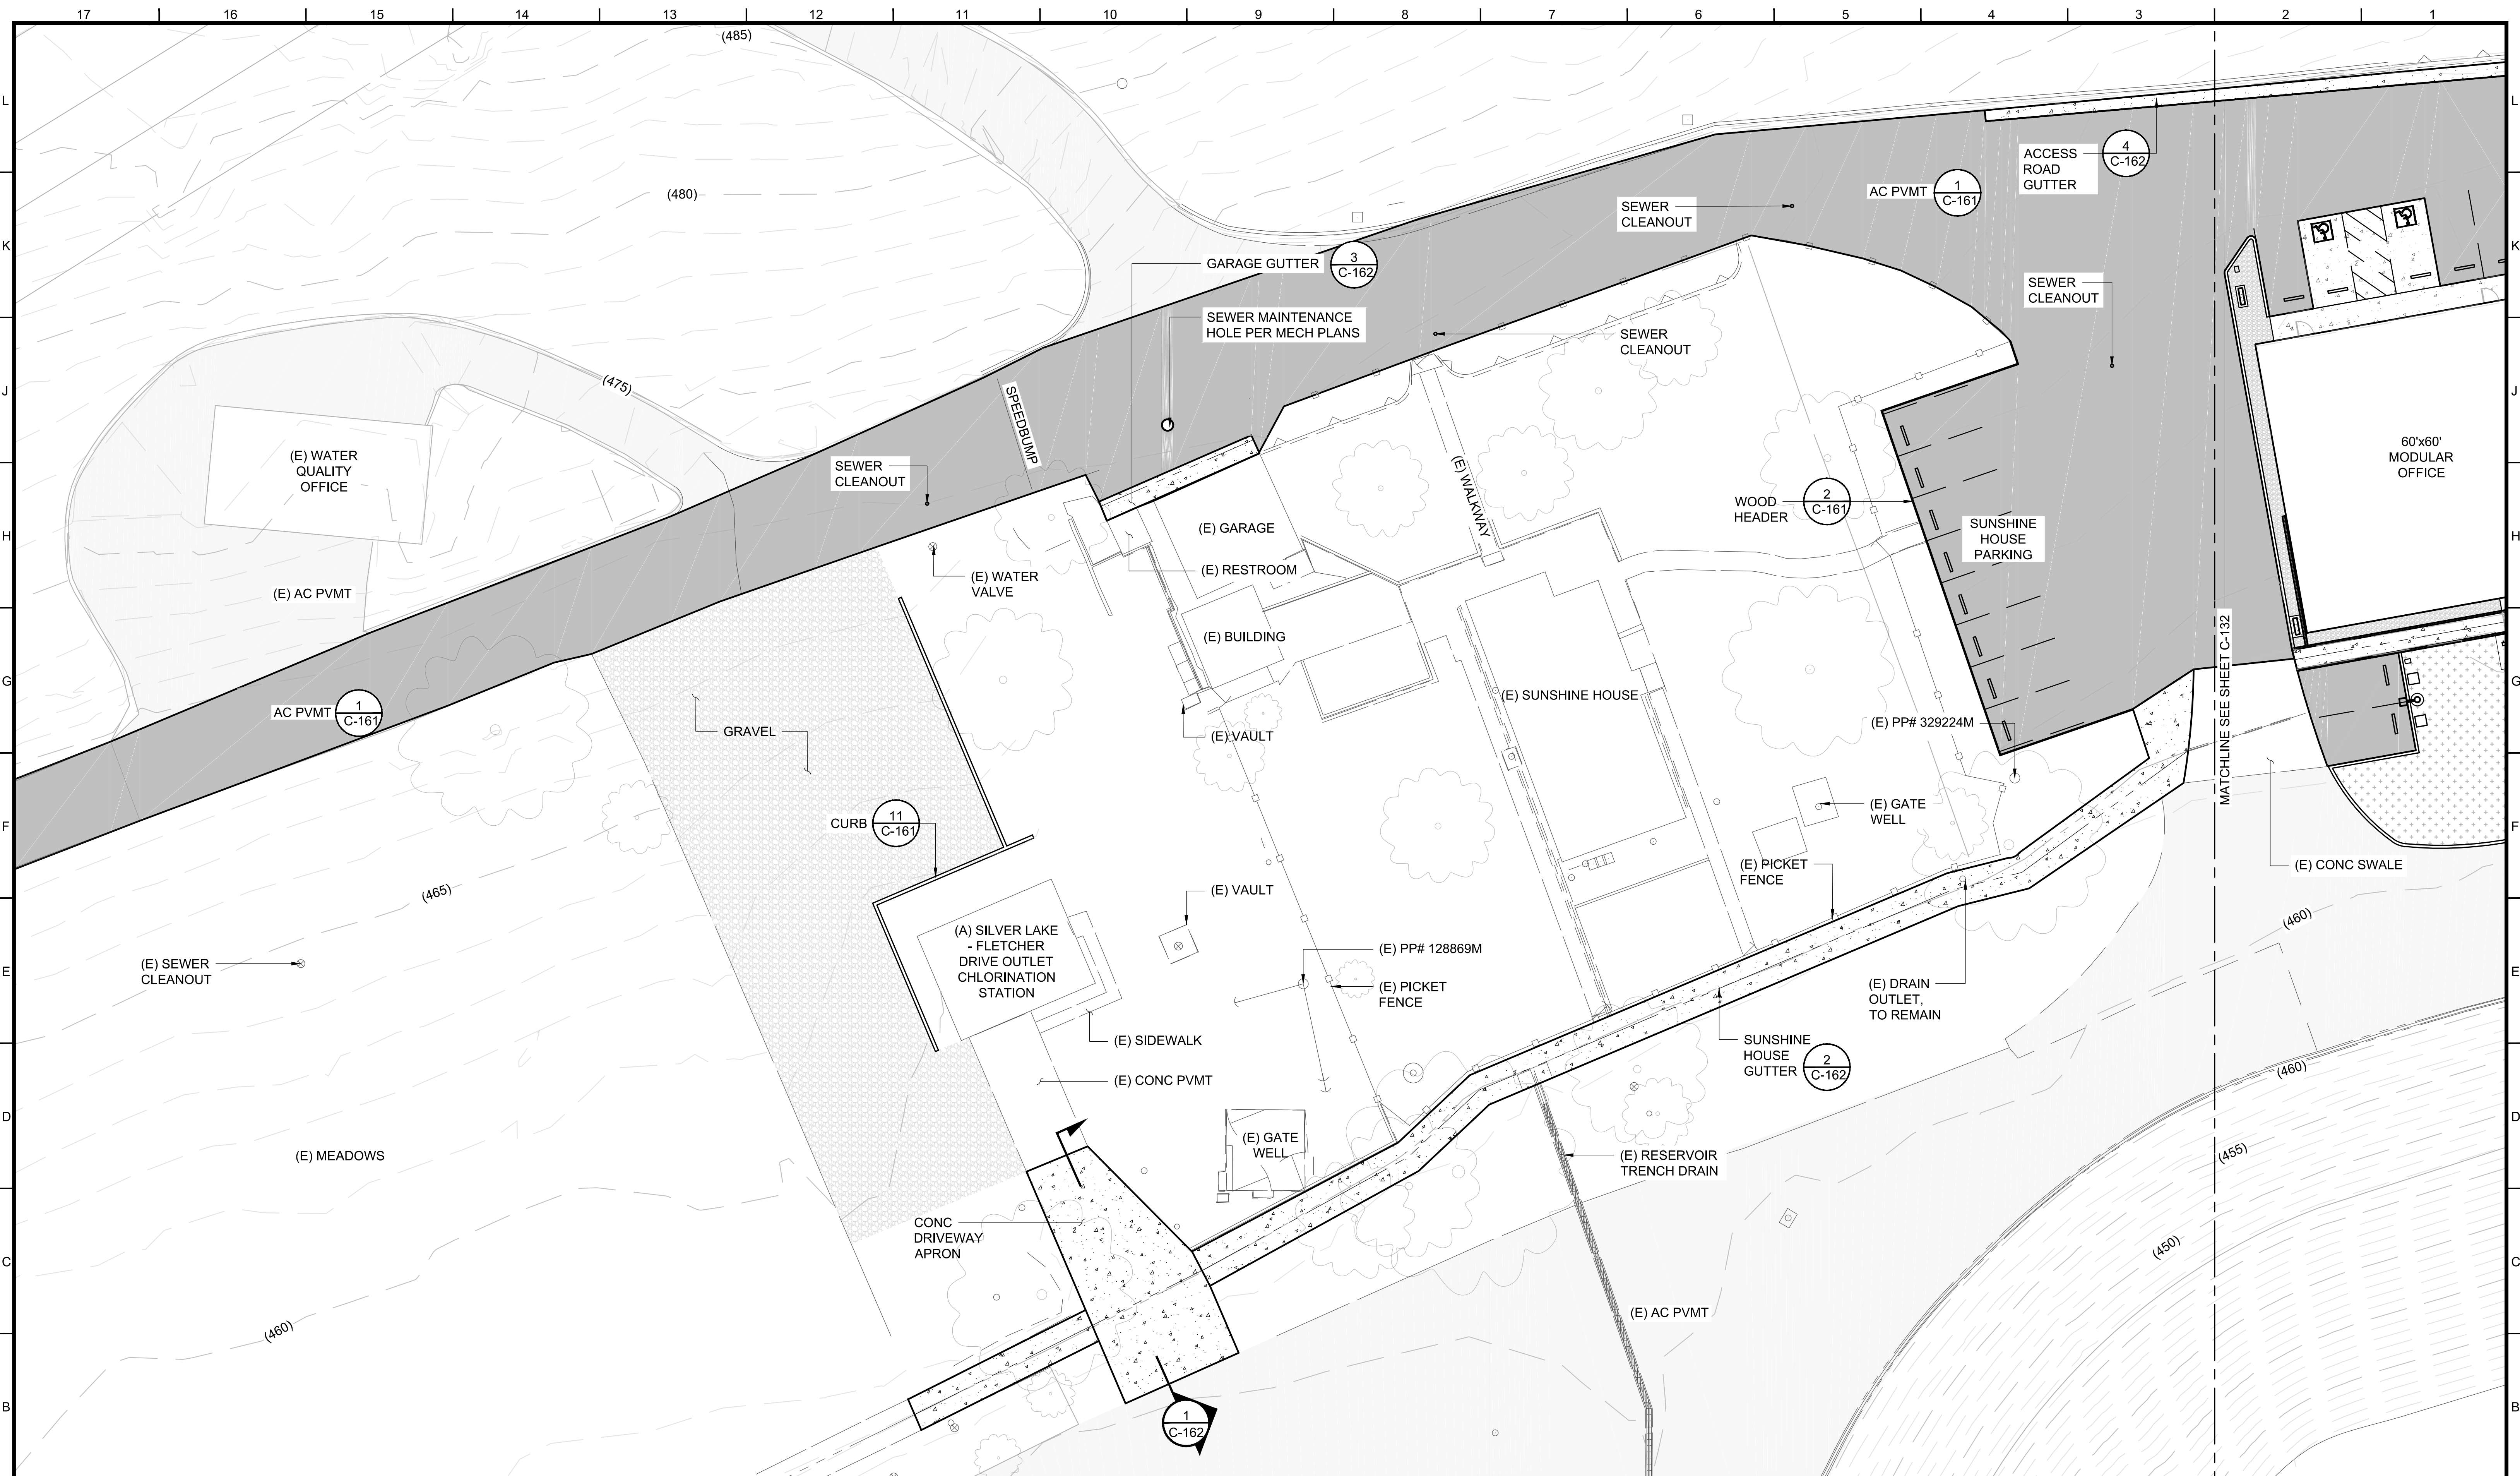

SITE PLAN - NORTH
SCALE: 1" = 15'

 

100% DESIGN
NOT FOR CONSTRUCTION

REVISIONS						
Number	Date	Initials	Location	Description	Approved	


REFERENCES			
Scale	AS SHOWN	DATE	APPROVED

Scale	AS SHOWN	DATE	APPROVED	DATE


SILVER LAKE RESERVOIR MODULAR OFFICE
SITE PLAN
NORTH

DEPARTMENT OF WATER AND POWER
CITY OF LOS ANGELES

DRAWING NUMBER
D06007-C-131

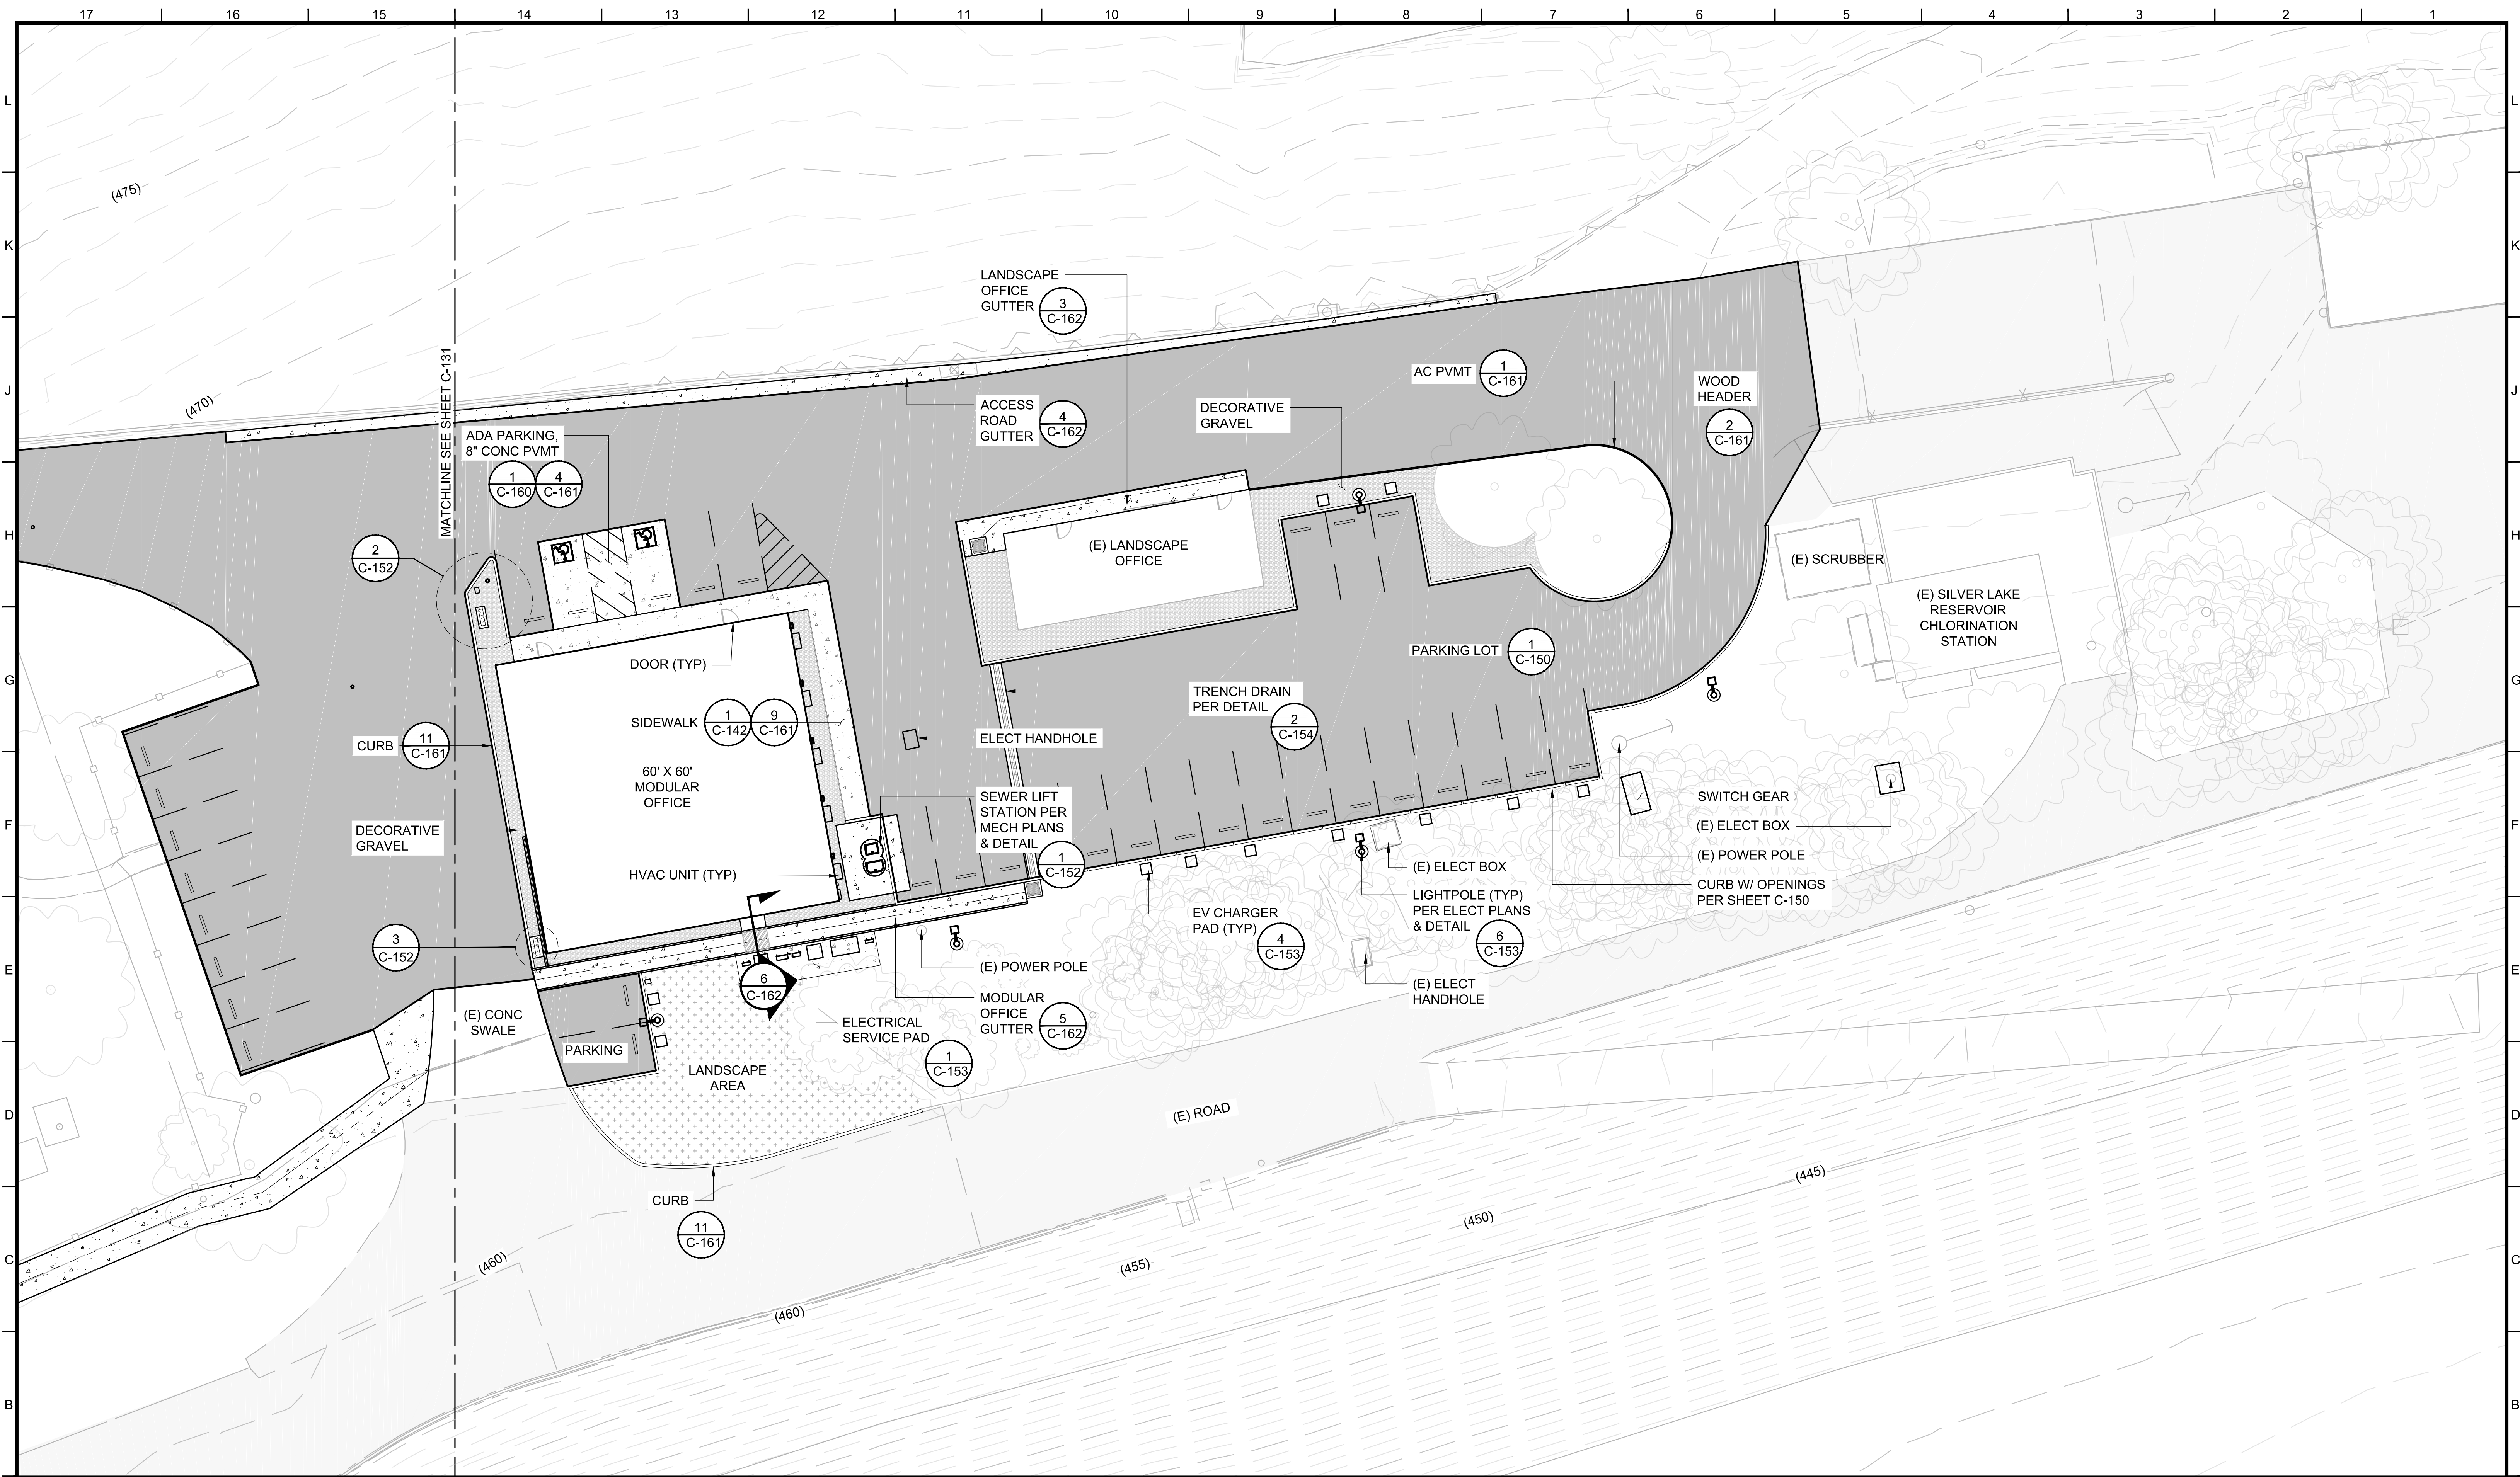

 SITE PLAN - SOUTH 1
 SCALE: 1" = 15'-0" C-130, C-131 C-132



100% DESIGN
 NOT FOR CONSTRUCTION

REVISIONS				
Number	Date	Initials	Location	Description

REFERENCES	
File Name	Description
C-132 SITE SOUTH.DWG	

Scale	AS SHOWN	DATE	APPROVED	DATE
Designer	C. USHJIMA	08/19	As to Design	
Assistant	ANDREW L. LINARD			08/19
Drawn By			As to Operation	
Checked By	R. CHANG	08/19	ANSELMO S. COLLINS	08/19
Last Update	GUSHI	09/03/19	As to Distribution	
Recommended	RAUSHAL R. PARBHO	08/19	BREONIA L. LINDSEY	08/19
			Senior Assistant GM of Water	
			RICHARD F. HARASICK	08/19

SILVER LAKE RESERVOIR MODULAR OFFICE
 SITE PLAN SOUTH


DEPARTMENT OF WATER AND POWER
 CITY OF LOS ANGELES

DRAWING NUMBER
D06007-C-132




PREFERRED MODULAR STRUCTURES
 3235 BELGIAN DRIVE
 NORCO, CA 92860
 PHONE: 951-735-2332
 FAX: 951-271-7797
 WWW.PREFERREDMODULAR.COM


THIS DRAWING IS THE PROPERTY OF PREFERRED MODULAR STRUCTURES. THIS DOCUMENT IN WHOLE OR IN PART, AND/OR ANY OF THE INFORMATION CONTAINED WITHIN MAY NOT BE REPRODUCED OR USED IN ANY MANNER WITHOUT THE EXPRESS WRITTEN CONSENT OF PREFERRED MODULAR STRUCTURES

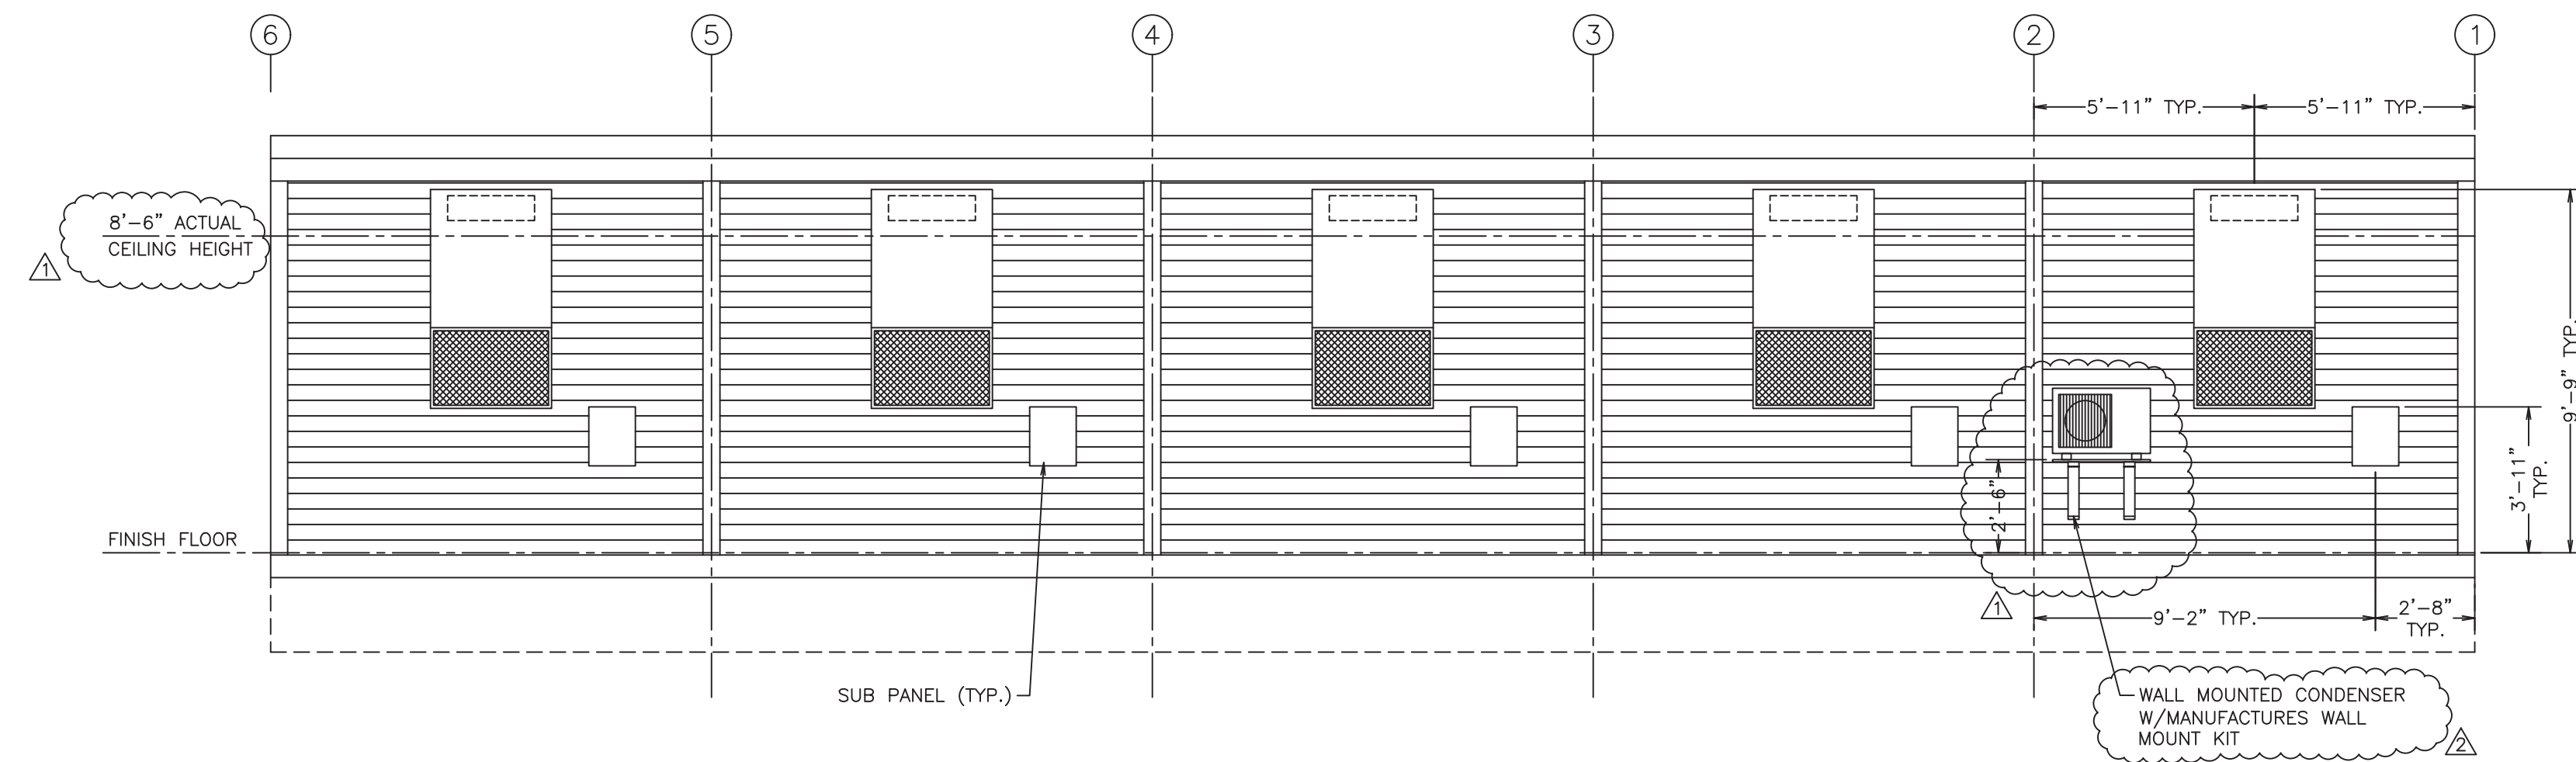


1 | ENDWALL ELEVATION

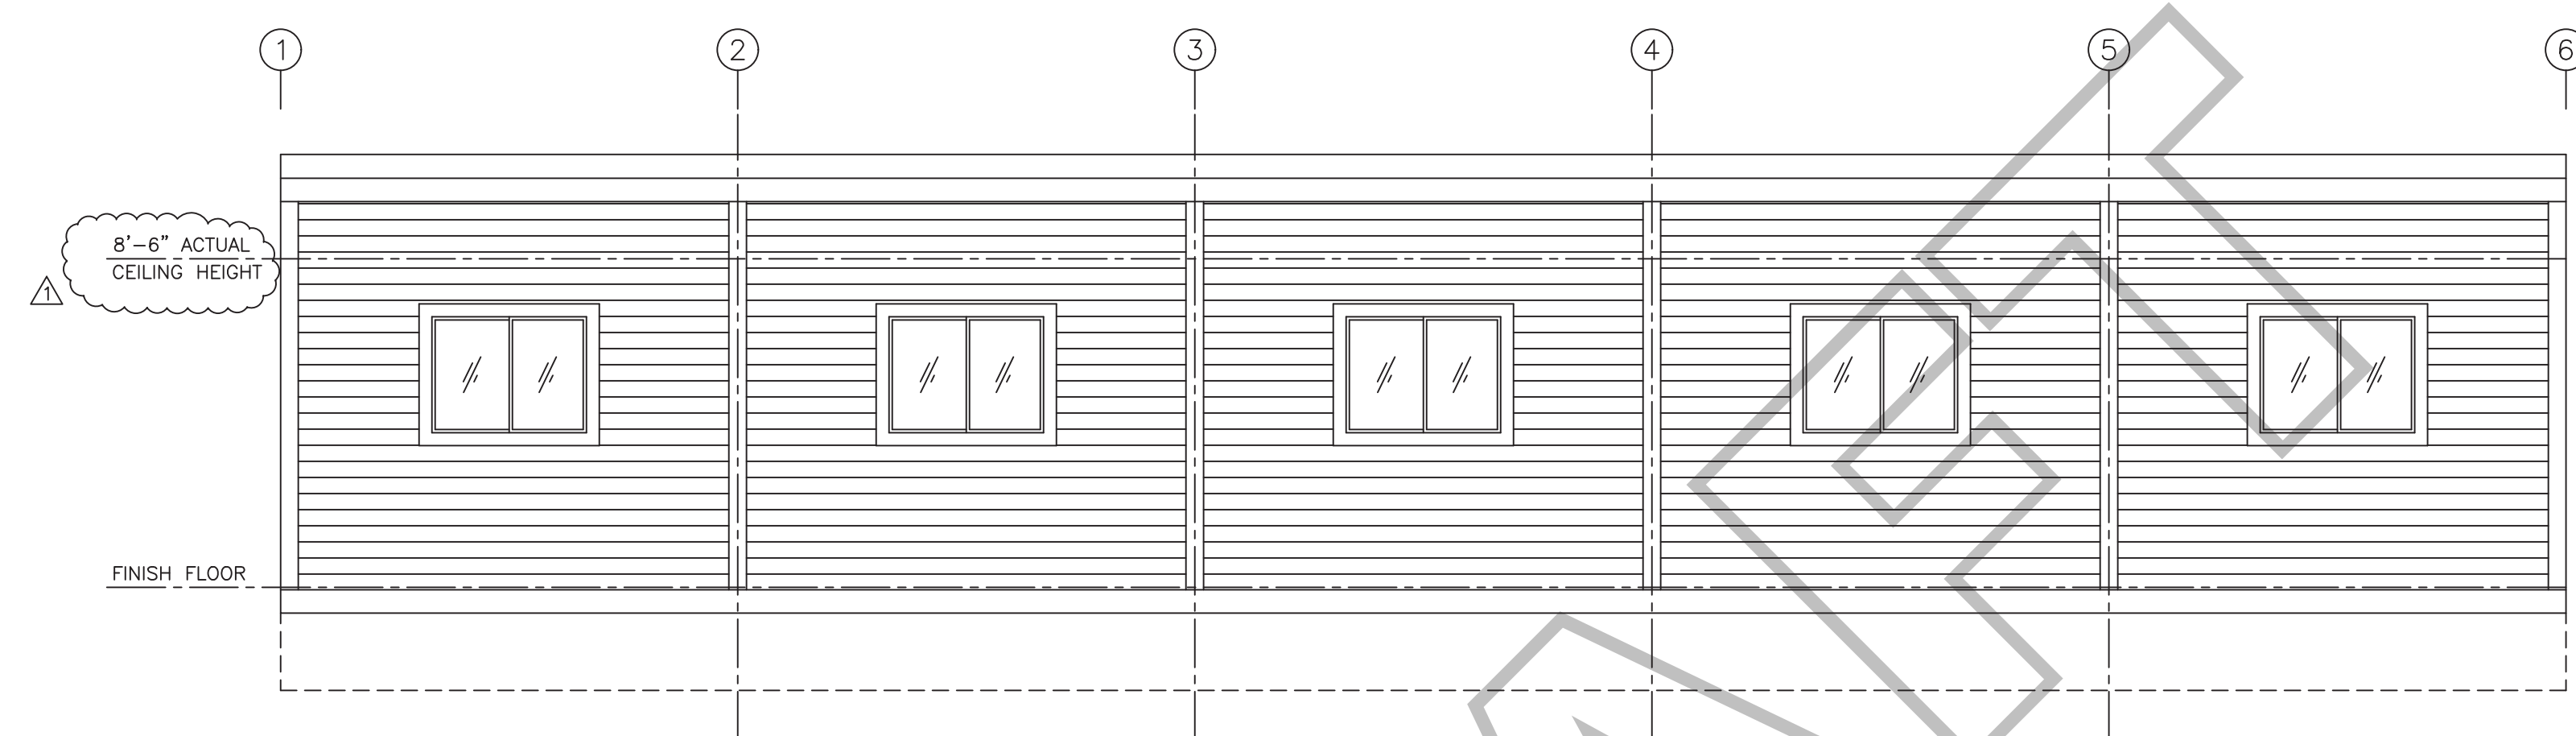

2 | ENDWALL ELEVATION

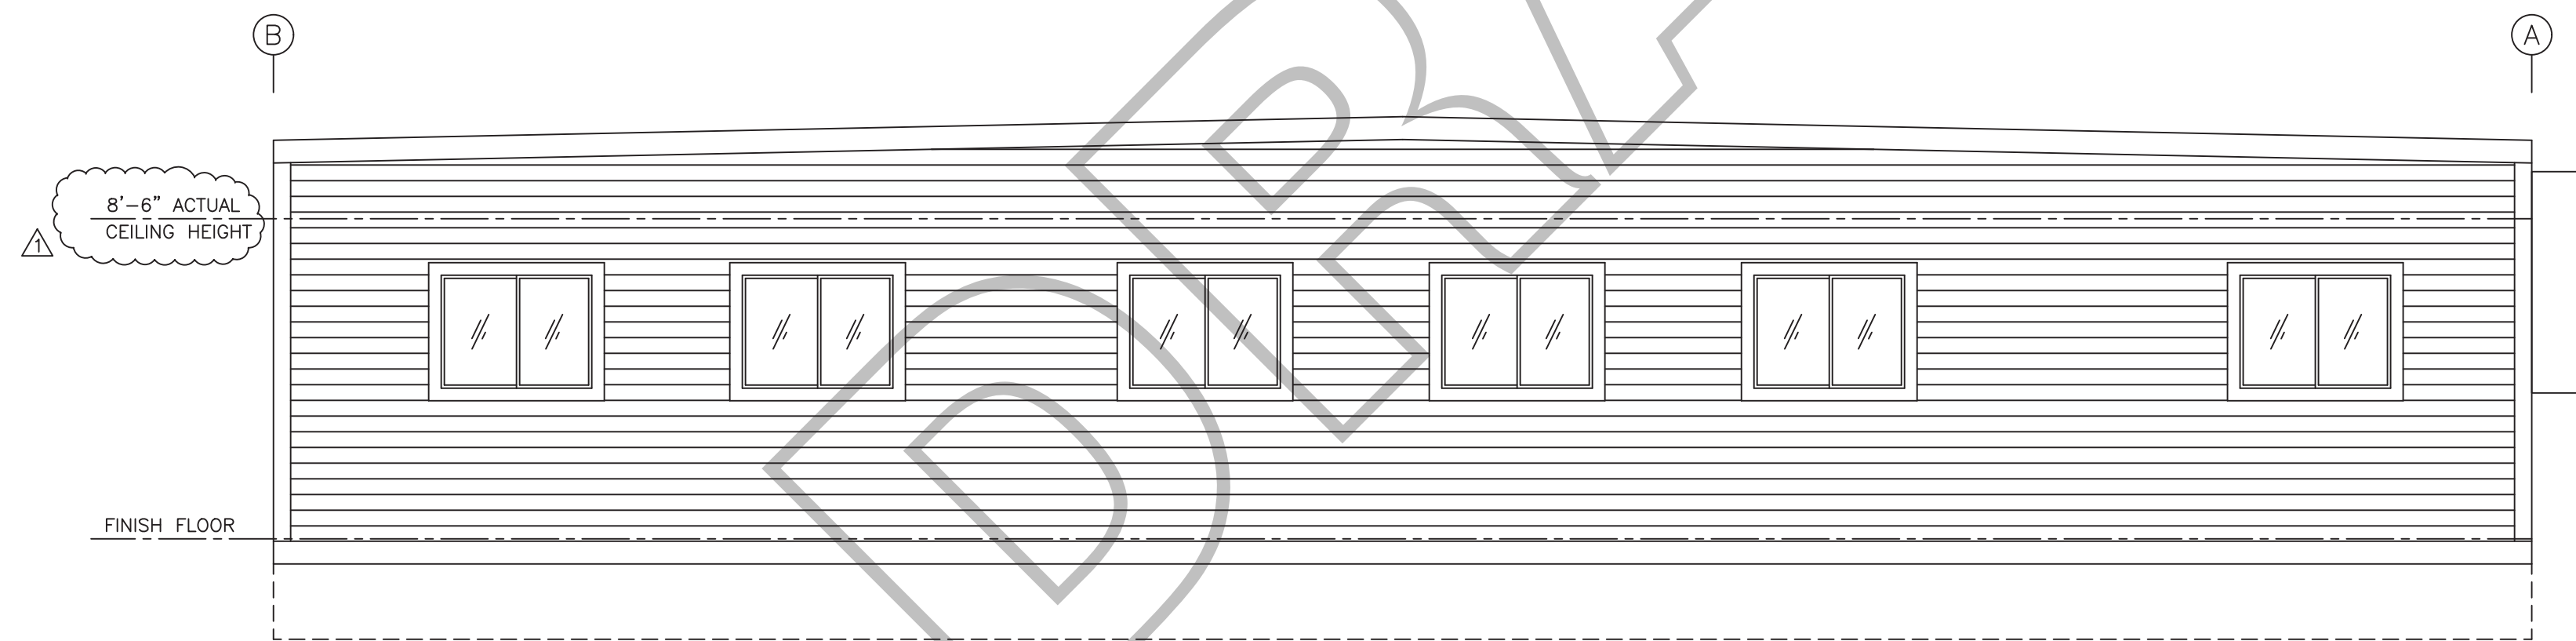

3 | SIDEWALL ELEVATION

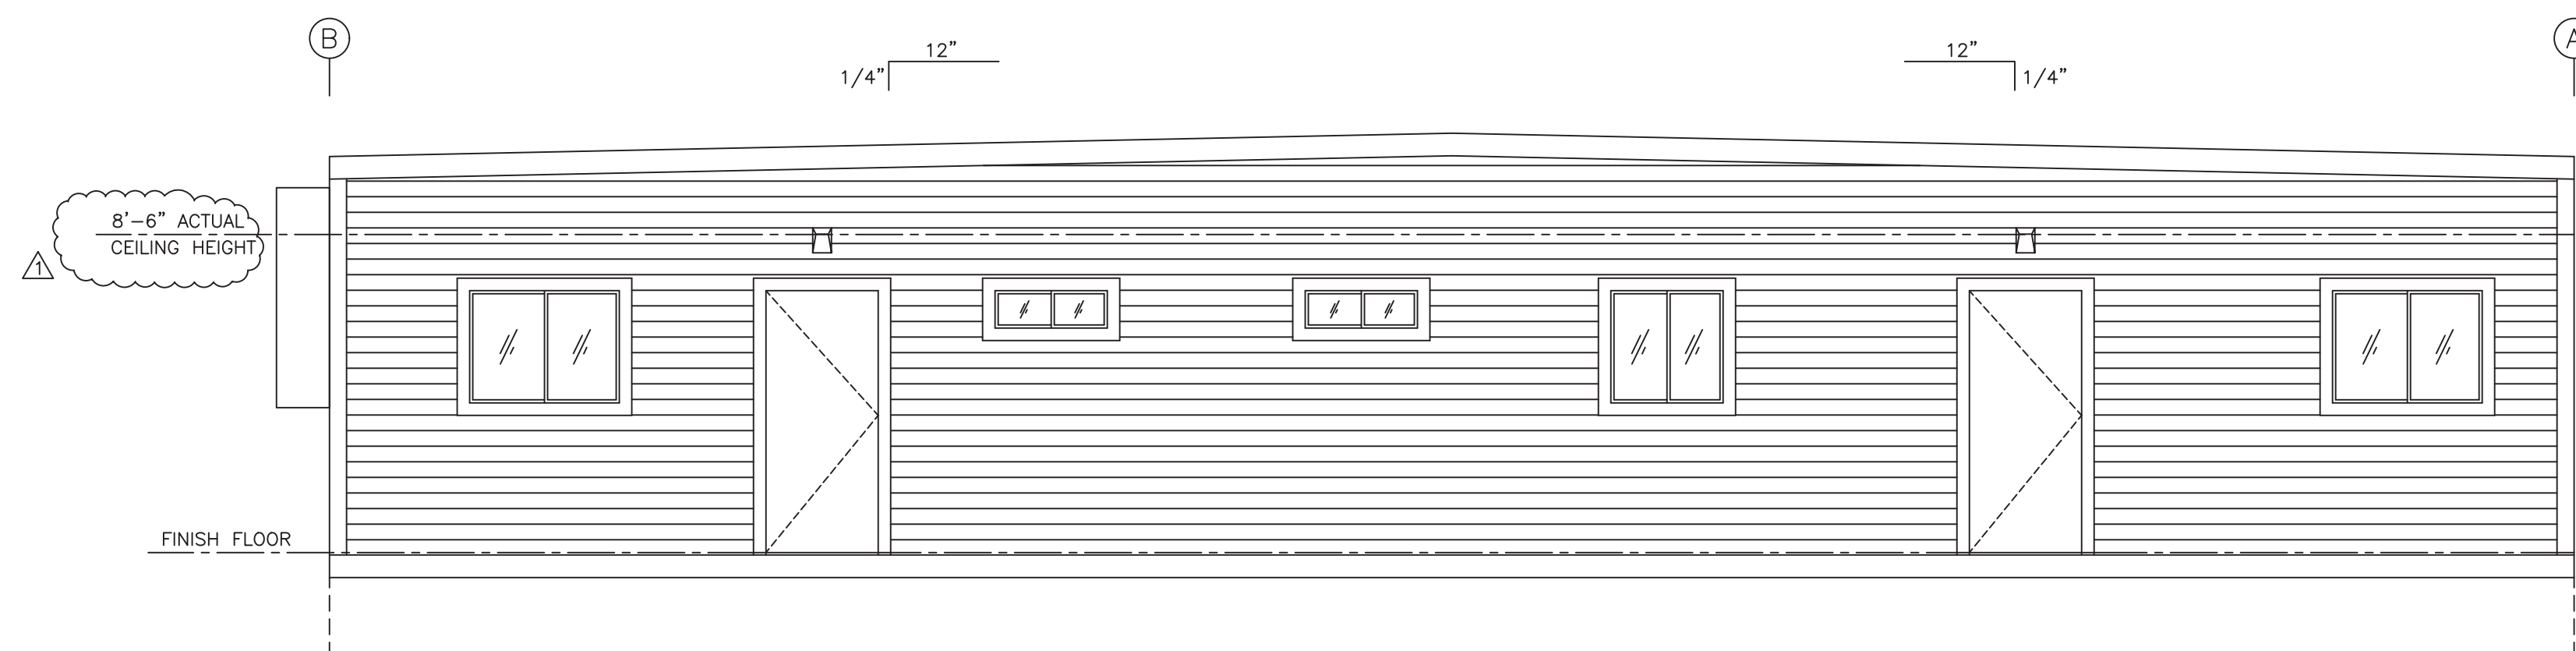

4 | SIDEWALL ELEVATION

REVISIONS	
1.	04-30-19 CLIENT
2.	05-19-19 CLIENT
3.	06-17-19 CLIENT
4.	06-19-19 CLIENT
5.	
6.	
7.	
8.	

PROJECT NAME
 (60'x60')
 LADWP P7794
 SILVER LAKE
 RESERVOIR FACILITY
 ITEM #4

CLIENT NAME
 LOS ANGELES DEPT OF WATER & POWER
 SILVER LAKE RESERVOIR FACILITY
 2700 TESLA AVE.
 LOS ANGELES, CA. 90039

DRAWING TITLE
 EXTERIOR ELEVATIONS

DRAWN BY
 KC
 PROJECT MANAGER
 MC
 SCALE
 1/4"=1'-0" (I.N.O.)
 DATE
 03/24/19
 SERIAL NUMBER
 XXXX

SIGN & DATE TO RELEASE FOR MANUFACTURE
 (SUBJECT TO PRICE VERIFICATION)
 PLANS APPROVED
 (AS NOTED) (W/CHANGES)

DATE
 SIGNATURE

PRELIMINARY
 06/19/19

SHEET NO.
 A-3